


Notes

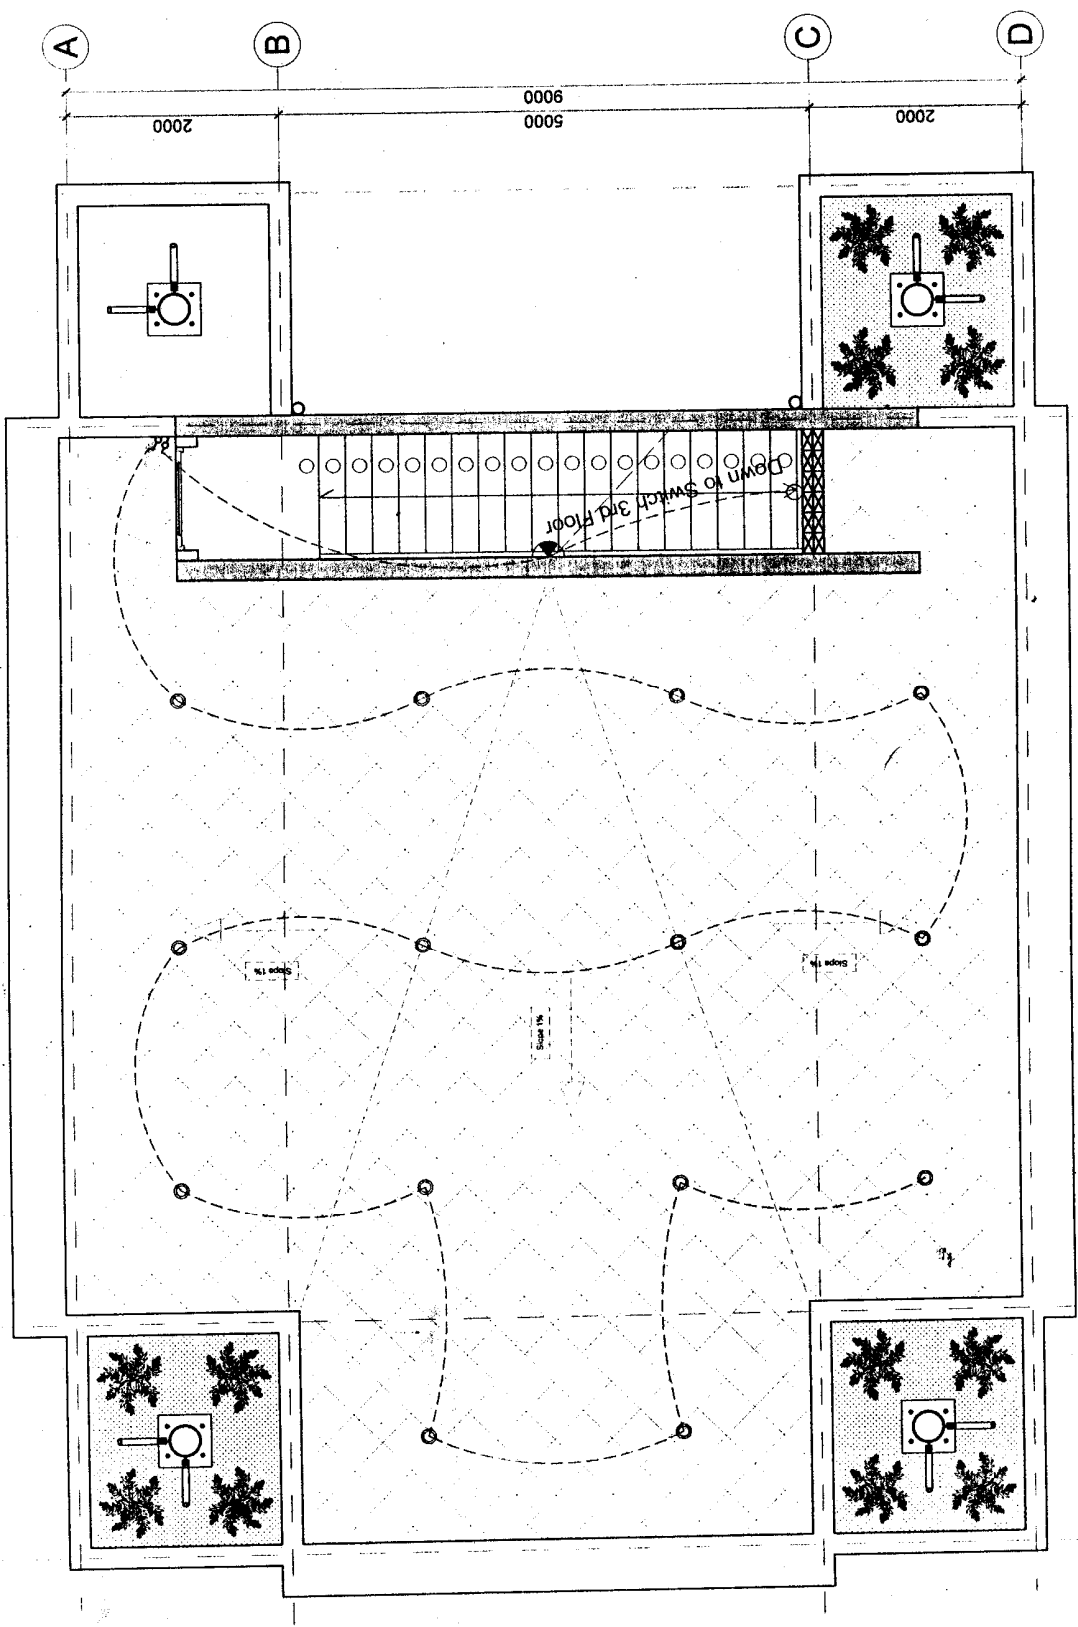

- Legend:**
- ⊕ Switch
 - ⊕ Switch two ways
 - ⊕ Socket
 - ⊕ Mainboard
 - ⊕ Television
 - ⊕ Telephone
 - ⊕ Internet
 - ⊕ Tube light
 - ⊕ Spot light
 - ⊕ Interior mounted light
 - ⊕ Airconditioner
 - ⊕ Ceiling Fan

Electrical Terrace Floor Plan
Scale: 1/50

Key Plan

Architect

L.B.L. INTERNATIONAL
ENTREPRISE GENERALE
BATIMENT - TRAVAUX PUBLICS
N° 24 Sahaesat boulevard
Phnom Penh, Cambodia
Tel: +855(0)23 722 332
Fax: +855(0)23 214 272
lbinformation@lbi-group.com
www.lbi-group.com



Client

H.E SAM RAINGSY

Project Name

H.E SAM RAINGSY'S OFFICE
N° ... Street 576, Sangkat chat angreueu, Chen meas
city, Phnom Penh
Tel: 092 888 003

Drawing Title

Electrical
Terrace Floor Plan

Designed by: JPM/BW
Checked by: JPM/BW
Drawn by: Sopheaktra
Approved by:
Date: 02-Feb-09
Scale: 1:50 @ A

Revisions

No.	Date	Drawn by	Description
A			
B			

Drawing number: LBL-ARC-SAM-PL-ELEC-C
Revision: